




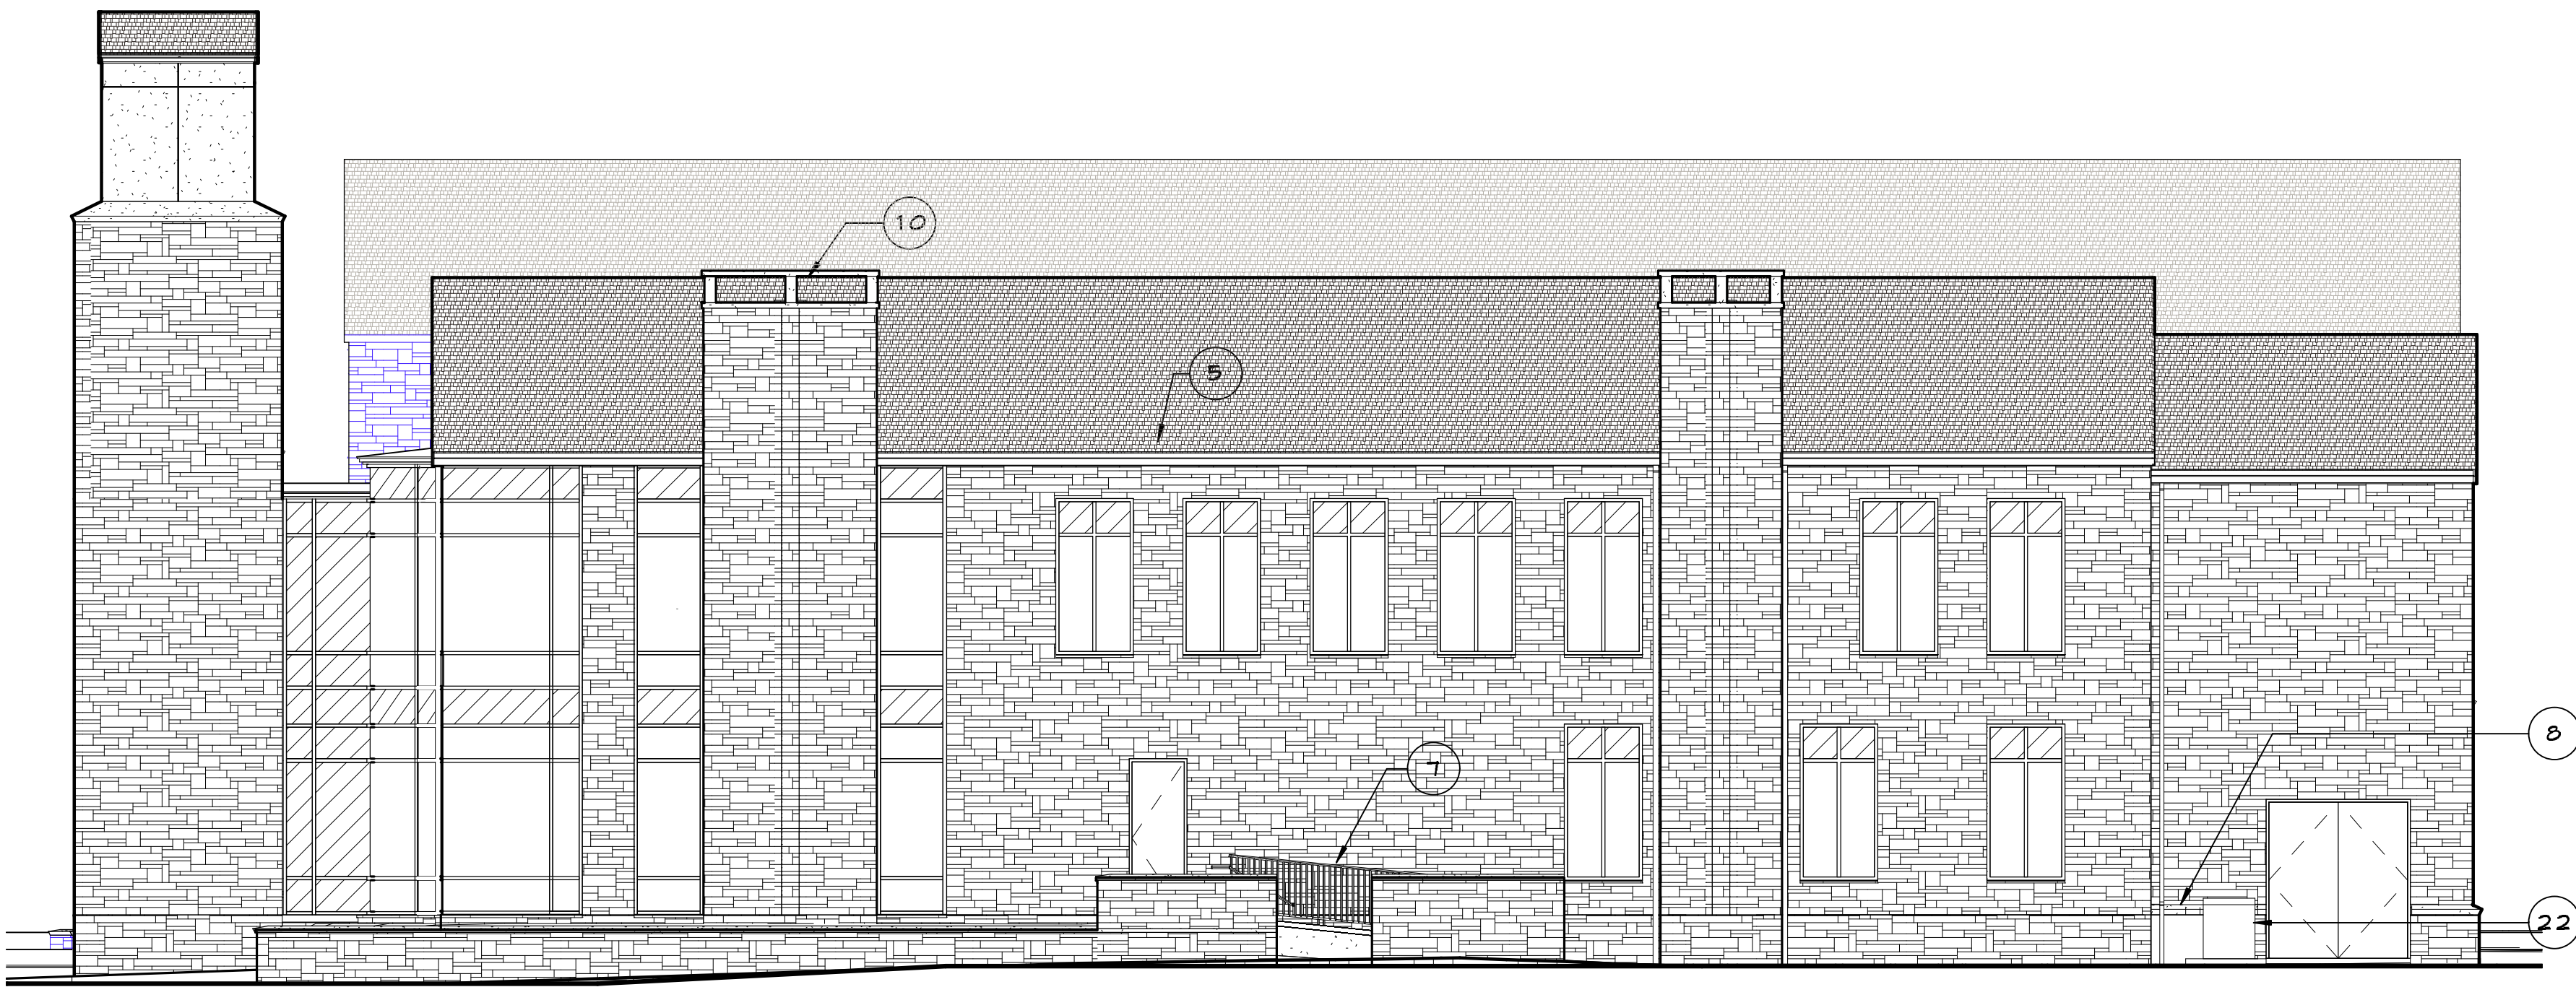


1 WEST ELEVATION
1/8" = 1'-0"

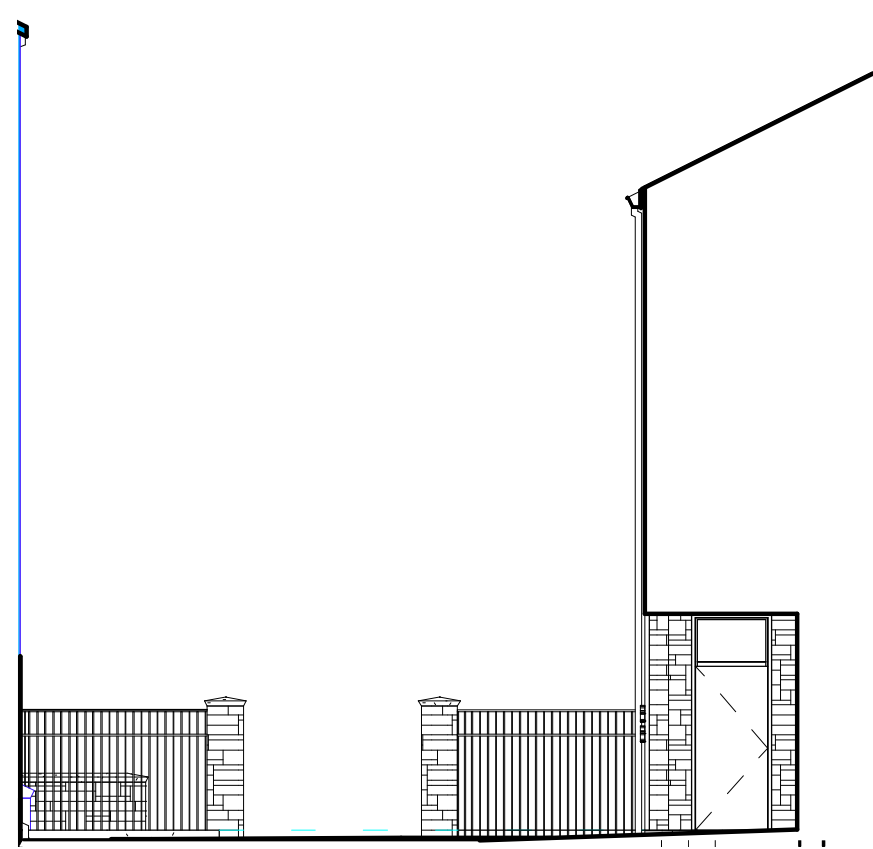


2 COURTYARD ELEVATION - SOUTH
1/8" = 1'-0"

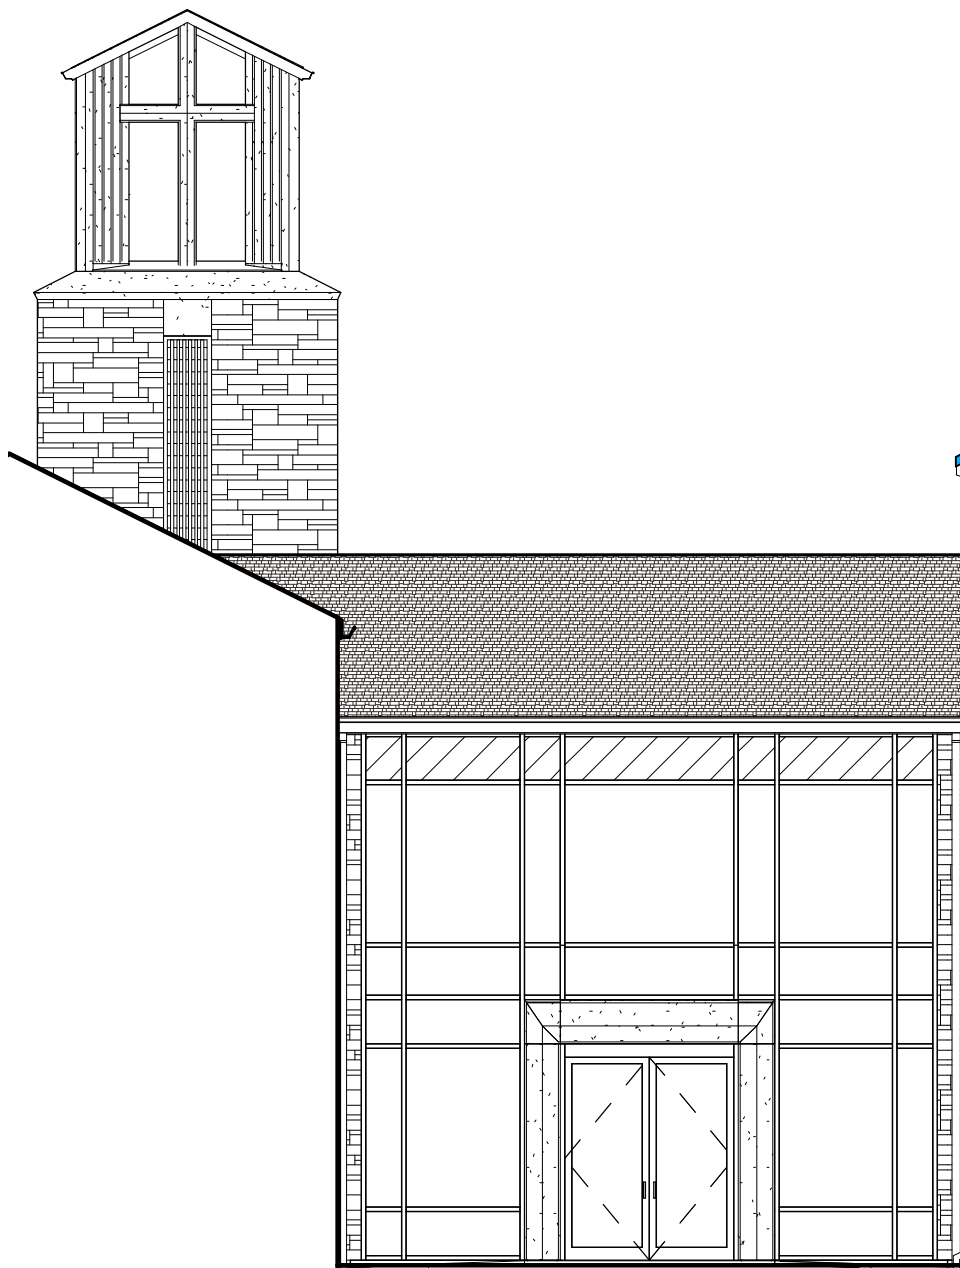

3 COURTYARD ELEVATION - NORTH
1/8" = 1'-0"

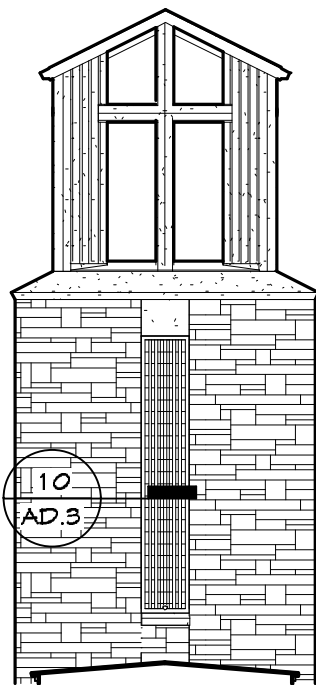

4 BELL TOWER ELEVATION - SOUTH
1/8" = 1'-0"

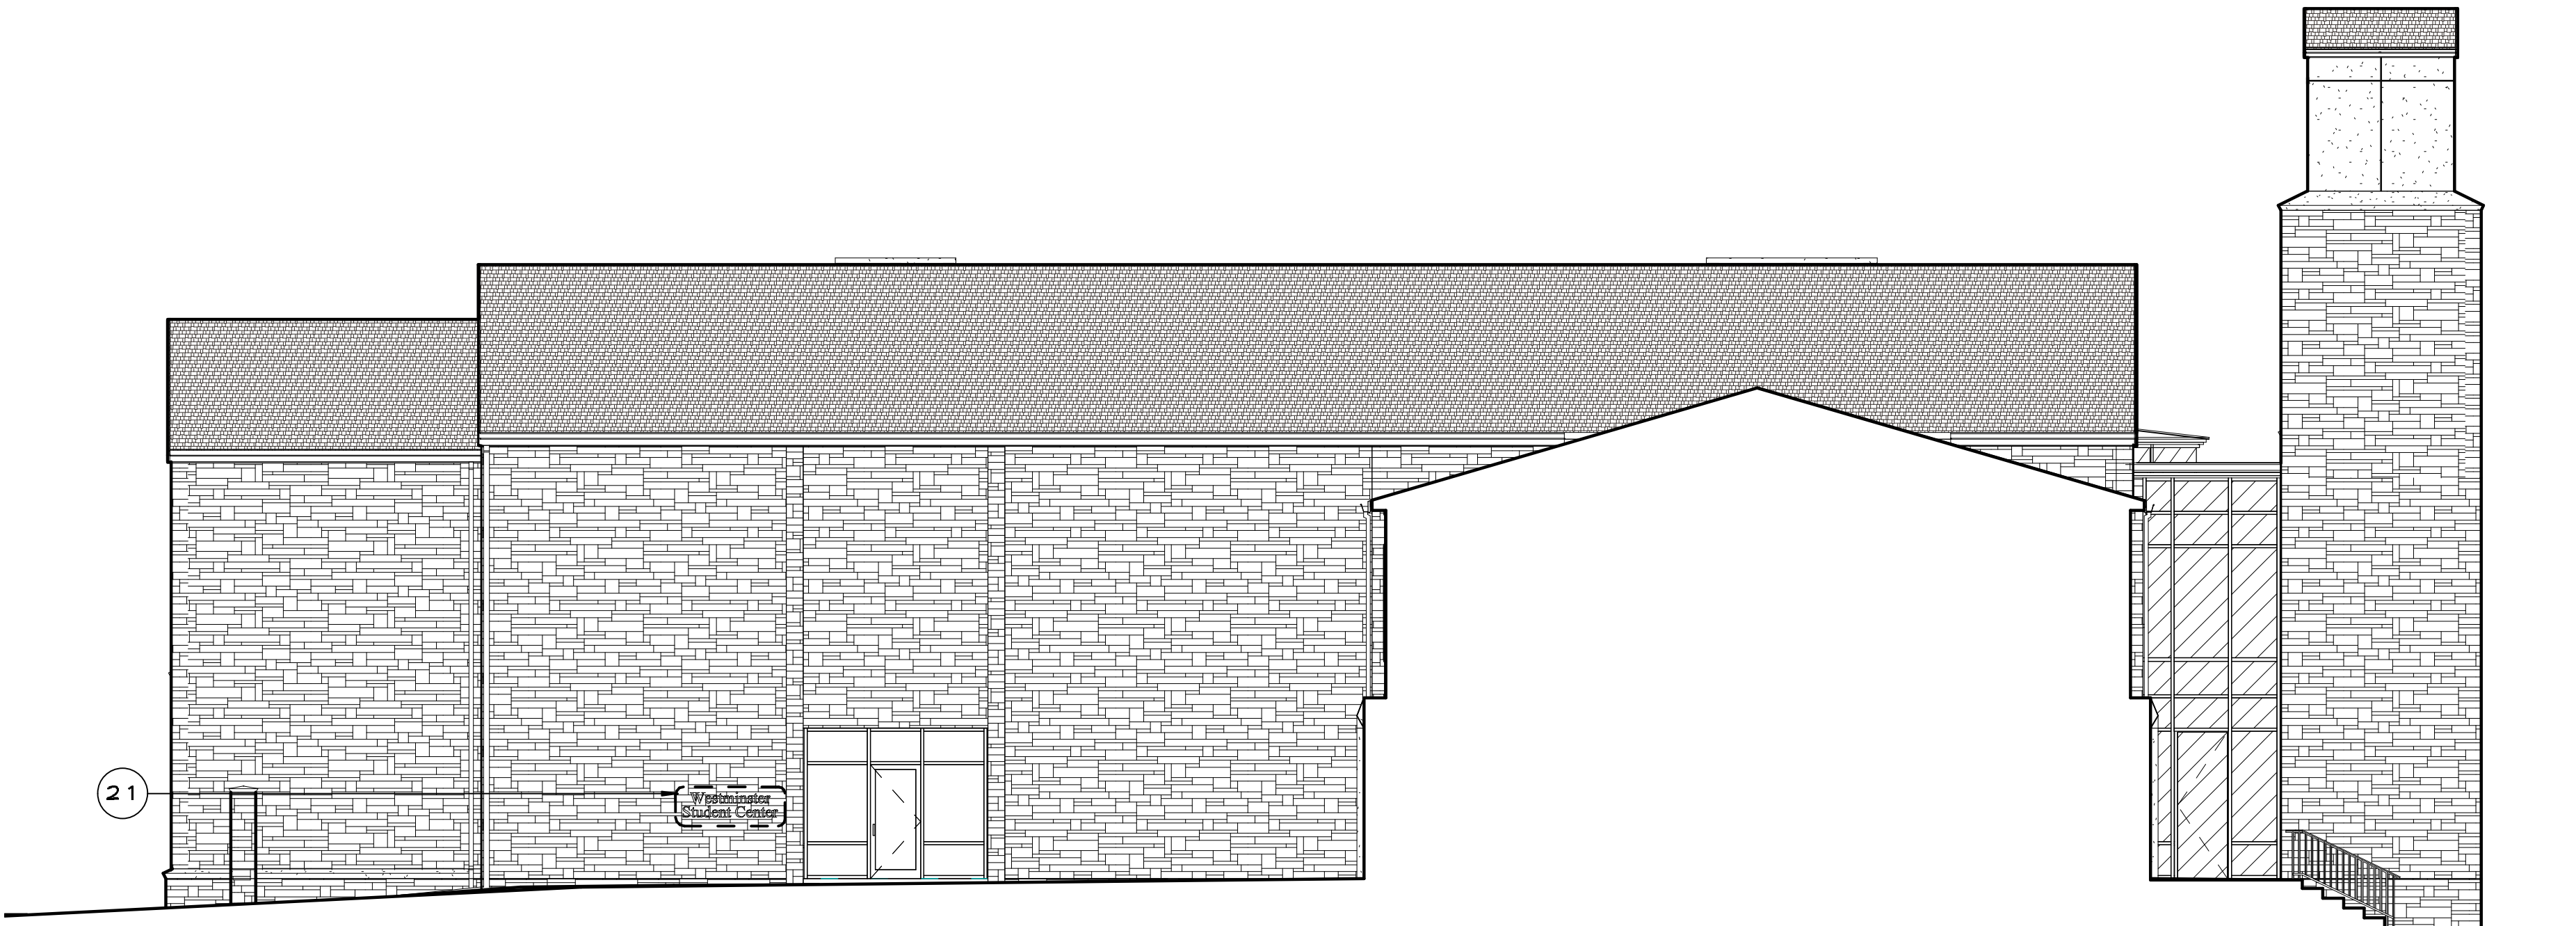

5 COURTYARD ELEVATION - EAST
1/8" = 1'-0"

KEYNOTES - EXTERIORS

- 1 Finish grade.
- 2 Stone veneer.
- 3 Cast stone.
- 4 Slate roofing.
- 5 Gutter, install level all locations.
- 6 Downspout.
- 7 Metall railing.
- 8 Cast stone wall trim.
- 9 Chimney.
- 10 Chimney cap.
- 11 Cast iron boot to storm water drainage system.
- 12 Cast stone panels.
- 13 New cast stone panels to match existing in size and thickness.
- 14 New construction.
- 15 Existing construction.
- 16 Existing signage.
- 17 New rectangular D.S. location; match existing size & patch gutter water tight @ exist tie-in.
- 18 New continuous face flashing @ existing exposed glue-lams.
- 19 Extend existing vertical D.S. section to new french drain system - match existing D.S.
- 20 Remove existing horizontal section of D.S.
- 21 Cast metal letters Re: spec's. Sign to read "Westminster Student Center".
- 22 Transformer Re: mechanical plans.

REMODEL AND
ADDITION TO:
SHARP CHAPEL

Sharp Memorial
Chapel

THE UNIVERSITY OF
TULSA
600 SOUTH
COLLEGE AVENUE
TULSA, OKLAHOMA
74 104

BRIAN
LLOYD
FREESE
ARCHITECTURE

CONSULTANT

SEAL

APPROVAL / DATE

KEY PLAN

DRAWN BY

DF / CT / G.M.V. / J.M.S.

SCALE

1/8" = 1'-0"

DATE

11/08/02

REVISED

11/08/02

PROJECT NO.

0101

FILE NAME

PAGE

EXTERIOR ELEVATIONS

A7.2